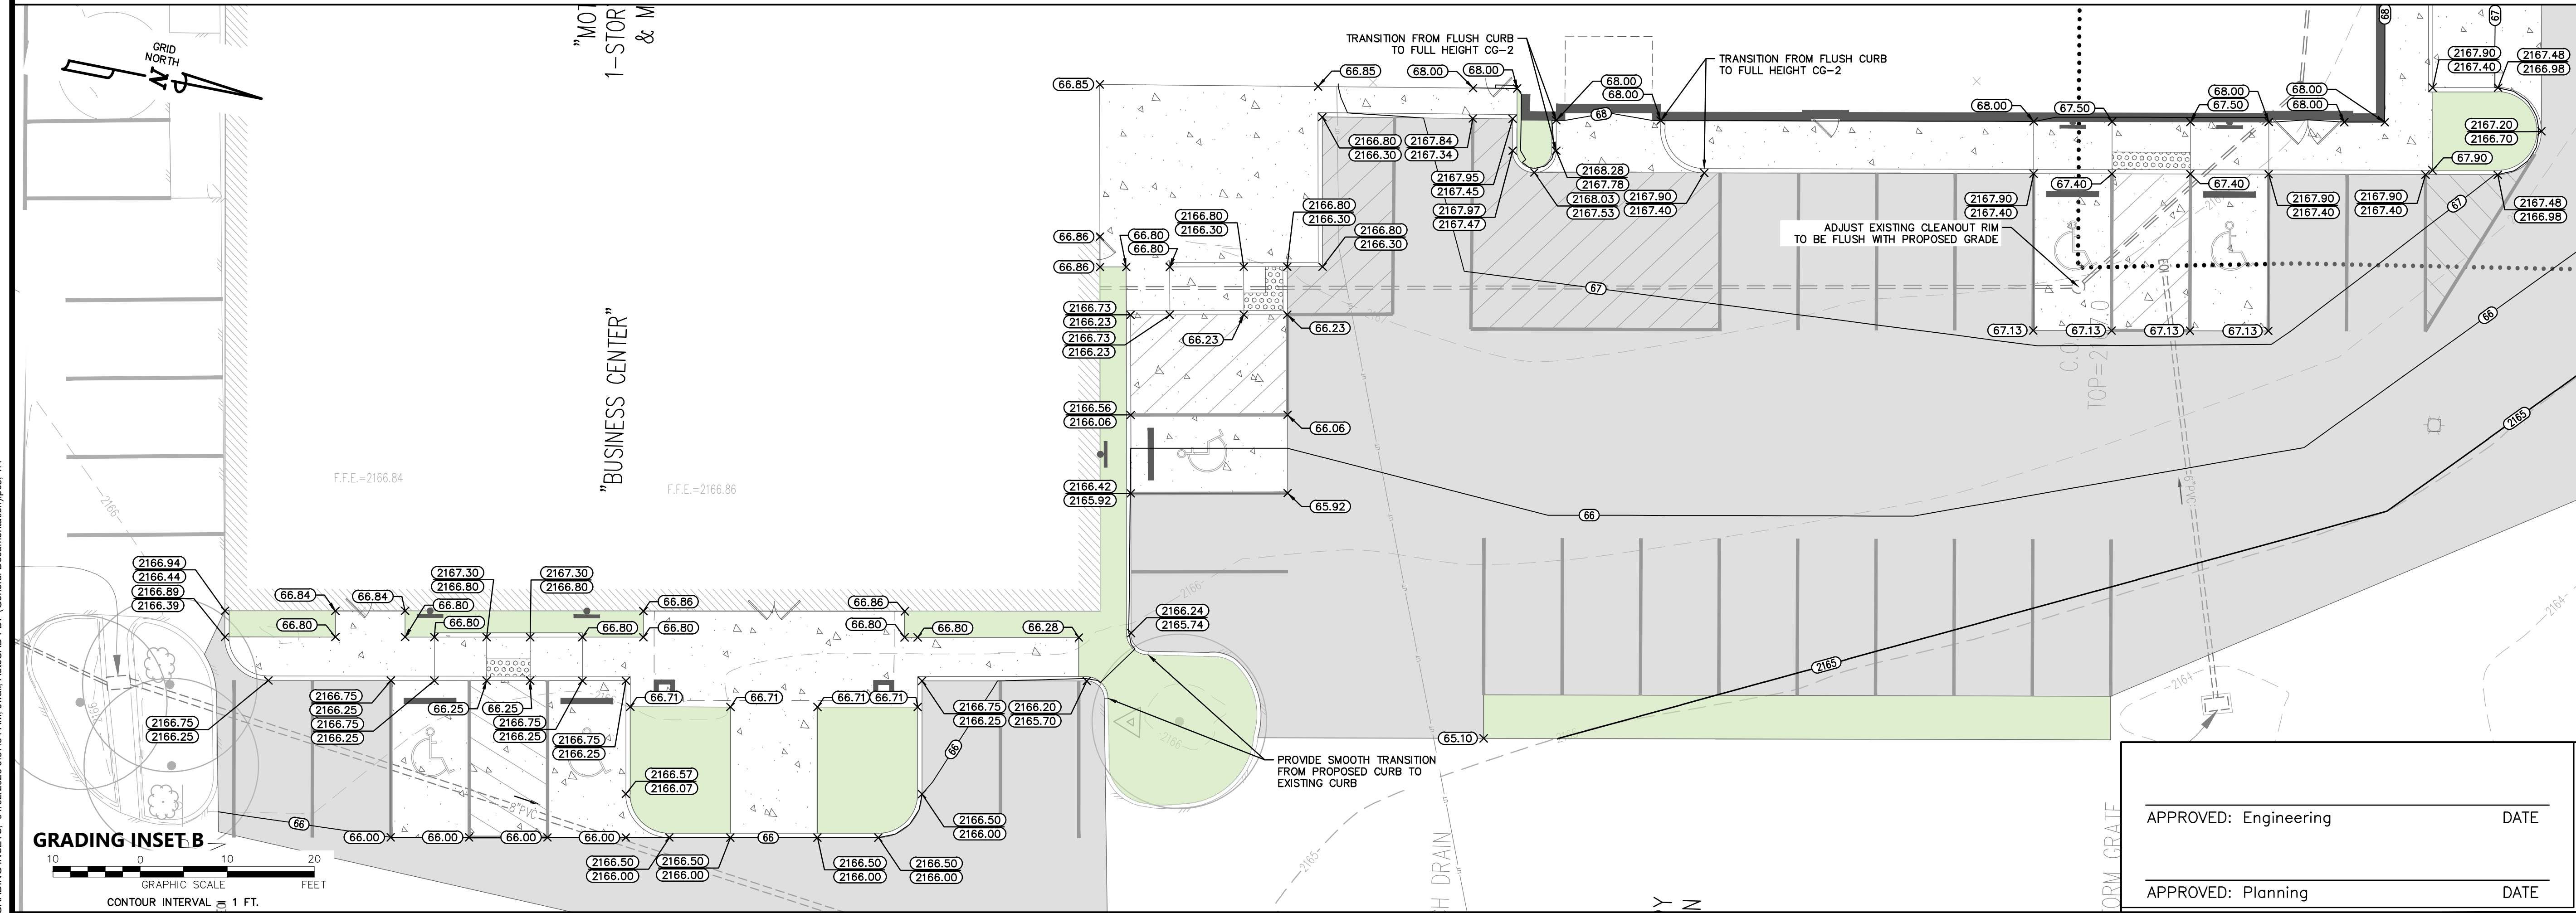
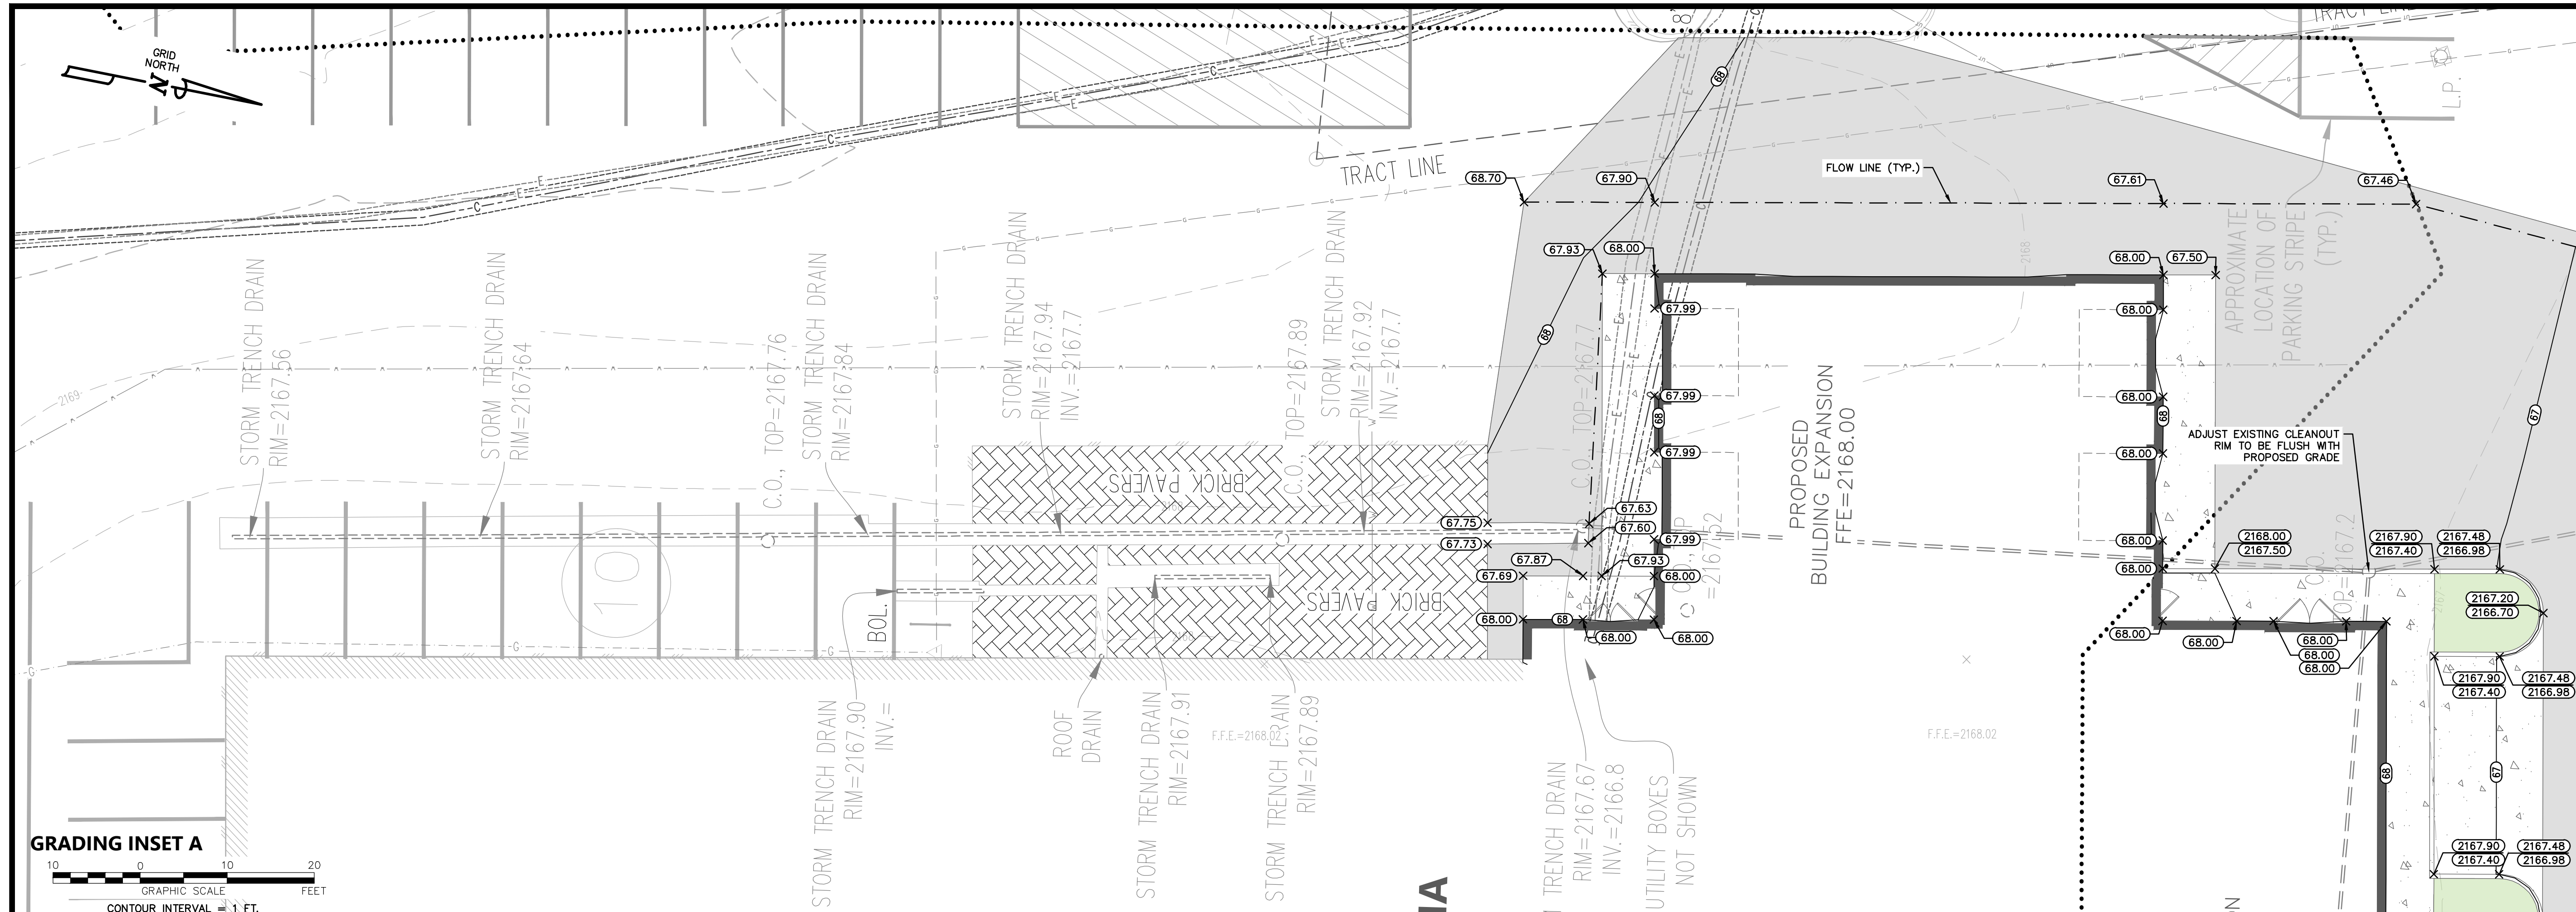


[illegible]

PROJECT TEAM	
PIC	JOHN T. NEEL, PE
PM	MATTHEW P. TOMLINSON, PE
DESIGN	JLW, ADS

ISSUE DATE
01/02/2026

FDS JOB NO.

3148

SHEET TITLE
GRADING PLAN INSETS

SHEET NUMBER
C3-02

APPROVED: Engineering

APPROVED: Planning DATE